

CIP # 15-002 - Oneida Community Wells

Project Description:

The project has three primary components: a Pumphouse, Water Main Extension, and new high capacity wells. These components are needed to address identified deficiencies in the water system noted in the *Master Plan for the Oneida Community Water System* prepared by Indian Health Service (IHS).

Current Status:


- New wells have been installed.
 - ◇ Water testing of new wells has determined extra conditioning needs to take place. Design is being revised to accommodate added equipment.
- The pumphouse and water main extension are currently being designed by Indian Health Service (IHS).

Schedule:

Approvals - complete.
 Design - IHS anticipates completion of design in fall 2023.
 Bidding - 2023
 Construction - 2024-2025
 Substantial Completion - 2025

Project Partners:

Utilities Dept., Land Management, Engineering, DPW, IHS

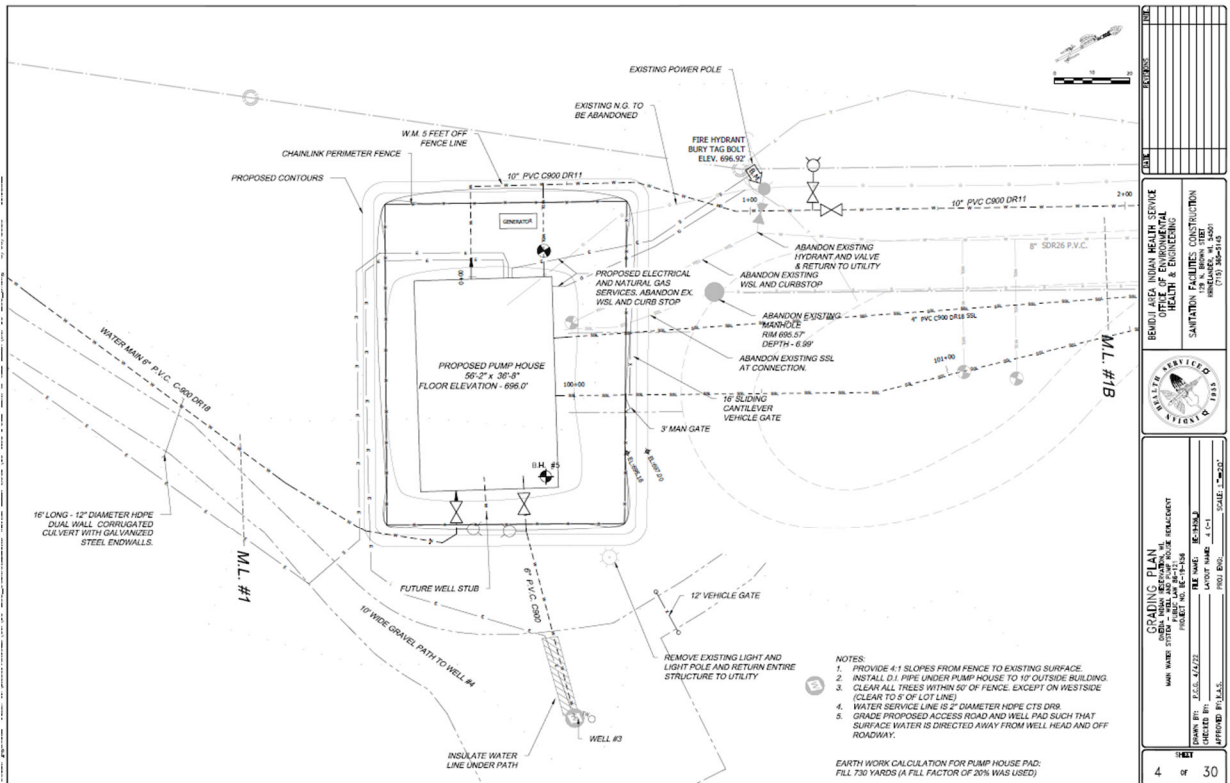

	REMONDIEE INDIAN HEALTH SERVICE CIVIL ENGINEER NO. 20154
	SANITATION FACILITIES CONSTRUCTION PROJECT NO. 15-002 SHEET NO. 15-002-143
GRADING PLAN DRAWN BY: JES, JAZZ CHECKED BY: JES, JAZZ PROJECT NO. 15-002 SHEET NO. 15-002-143 APPROVED BY: JES, JAZZ	
DATE: 10/30/23	SCALE: AS SHOWN 4 of 50